



N | Key Plan (Location Plan)  
 No Scale

**OR**




N | Key Plan (Location Plan)  
 No Scale

ABC Company  
 1000 W 8th St Ste 116

These are 2 different options for a key plan. If the tenant space exits into a common (shared) area, the bottom option is required. If all exits go directly to the outside, the top option is acceptable.




CITY OF  
**SIOUX FALLS**  
 PLANNING & DEVELOPMENT  
 SERVICES

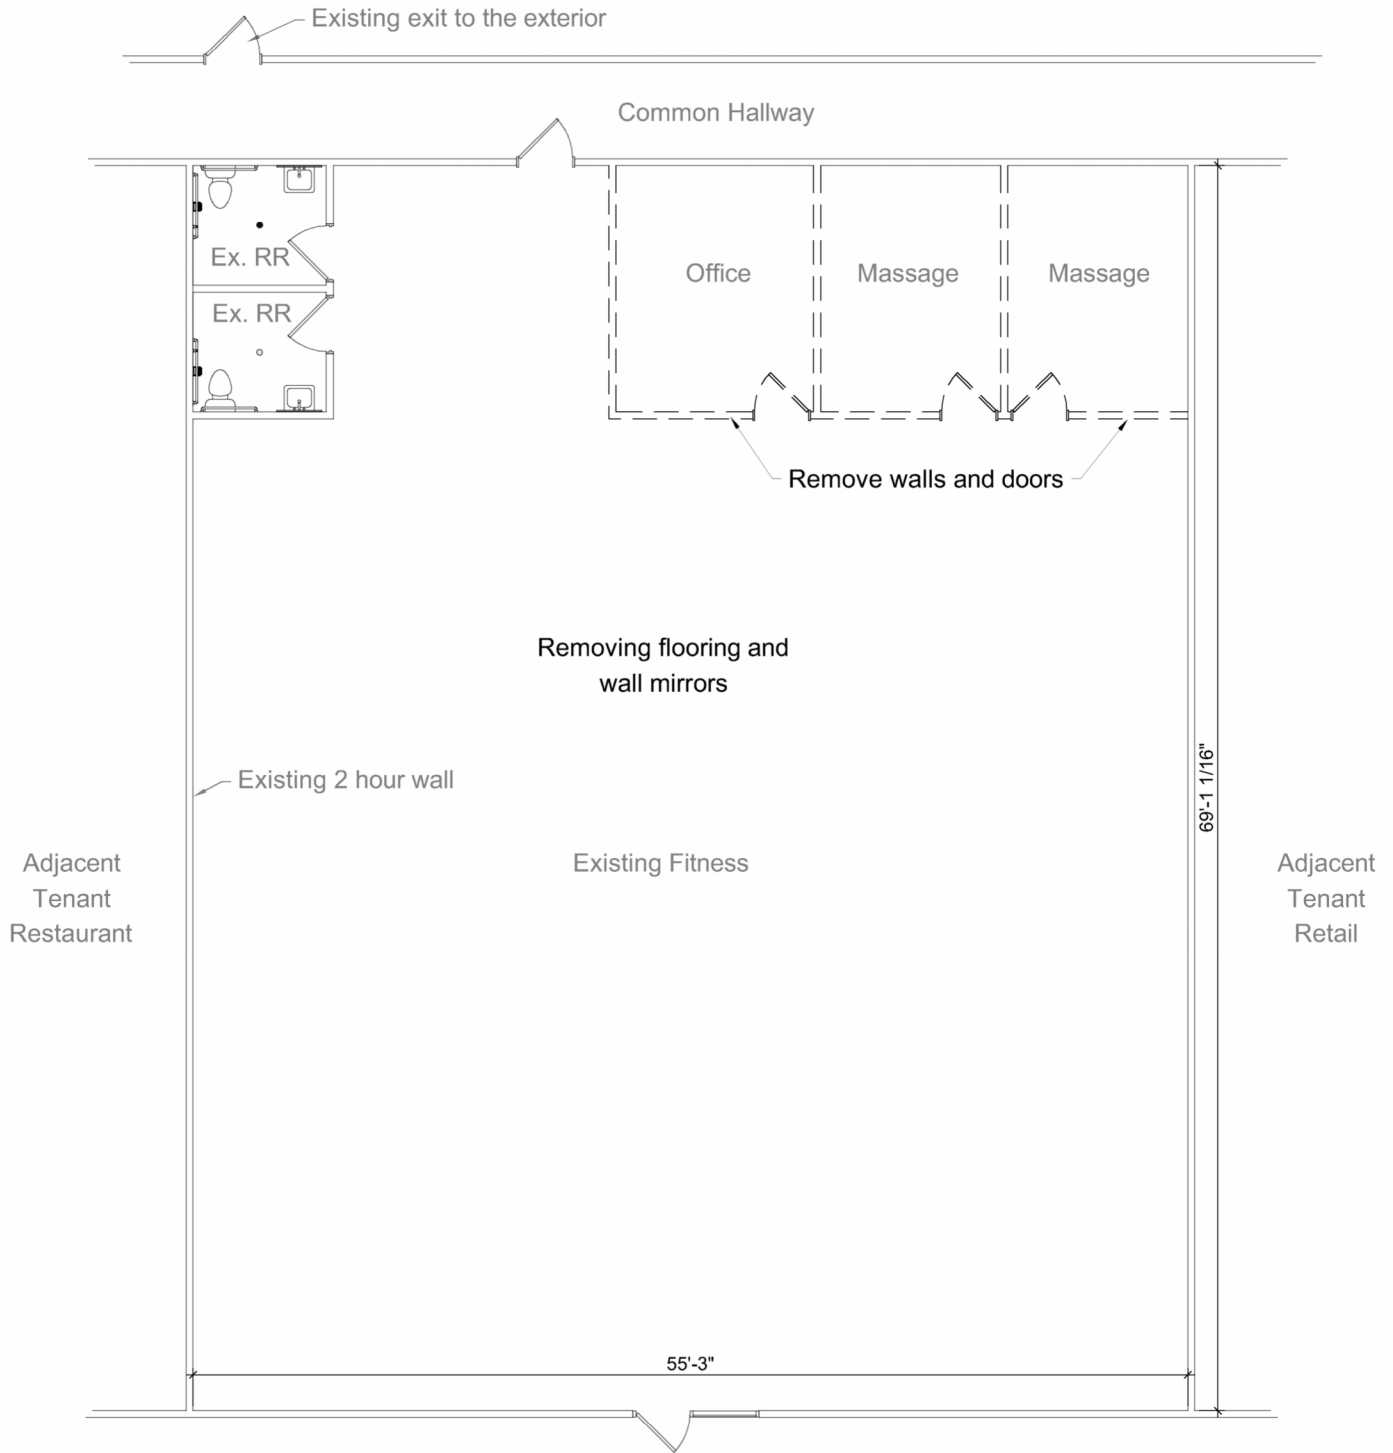


Existing Plan (if no items will be removed)  
 Demo Plan (if items will be removed)  
 Scale:  $\frac{3}{32}$ " = 1'-0"


ABC Company  
 1000 W 8th St Ste 116

This is an example plan showing existing elements (walls, doors, windows, plumbing fixtures, cabinets, counters, racks, seating, equipment) and existing room labels in light lines.  
 No new (proposed) items are shown.

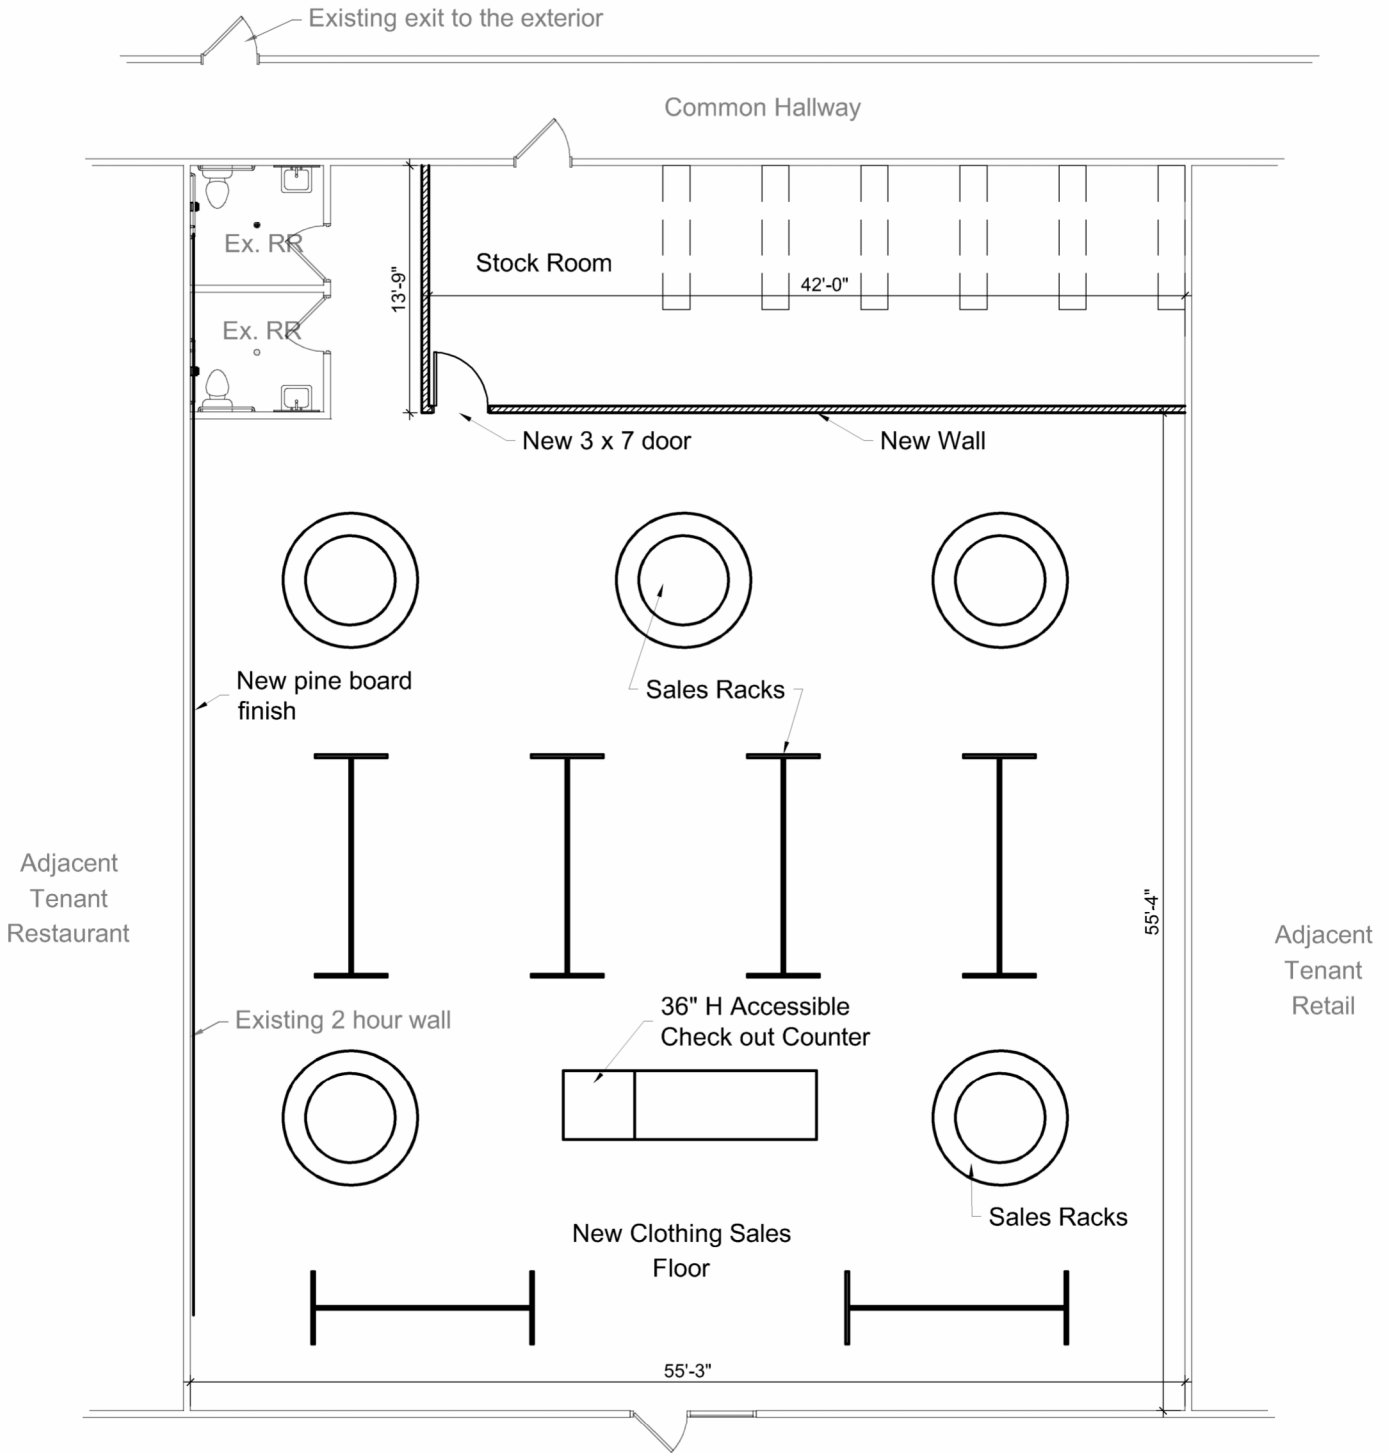

\*NFPA 13 throughout building

   
 New Wall - 2 x 6 Wood  
 - 5/8" GWB

 **Floor Plan**  
 Scale: 3/32" = 1'-0"

ABC Company  
 1000 W 8th St Ste 116

This is an example plan showing existing elements (walls, doors, windows, plumbing fixtures, cabinets, counters, racks, seating, equipment) and existing room labels in light lines.

All new (proposed) items are shown in dark lines and labeled.